

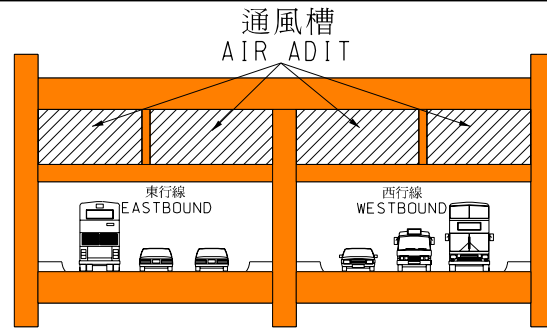


典型鑽挖式隧道橫切面
TYPICAL SECTION FOR BORED TUNNEL
不按比例 N.T.S.

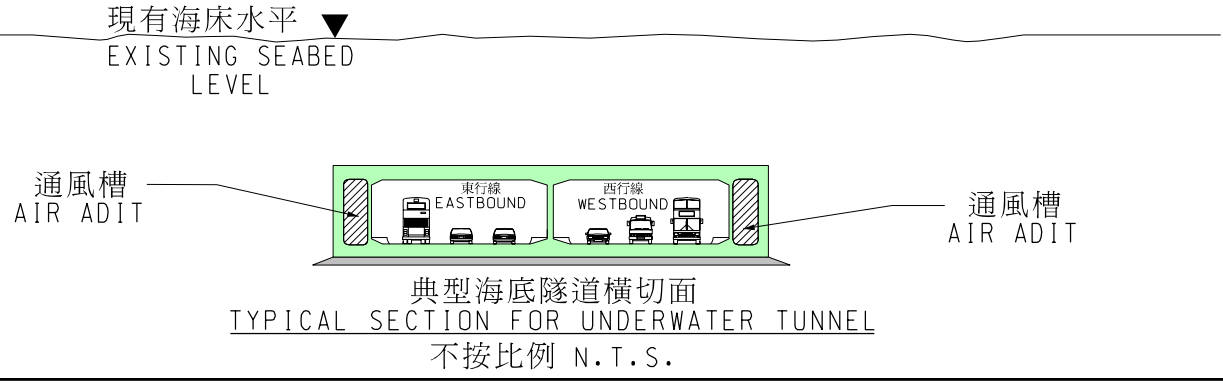

典型明挖回填式隧道橫切面
TYPICAL SECTION FOR CUT-AND-COVER TUNNEL
不按比例 N.T.S.

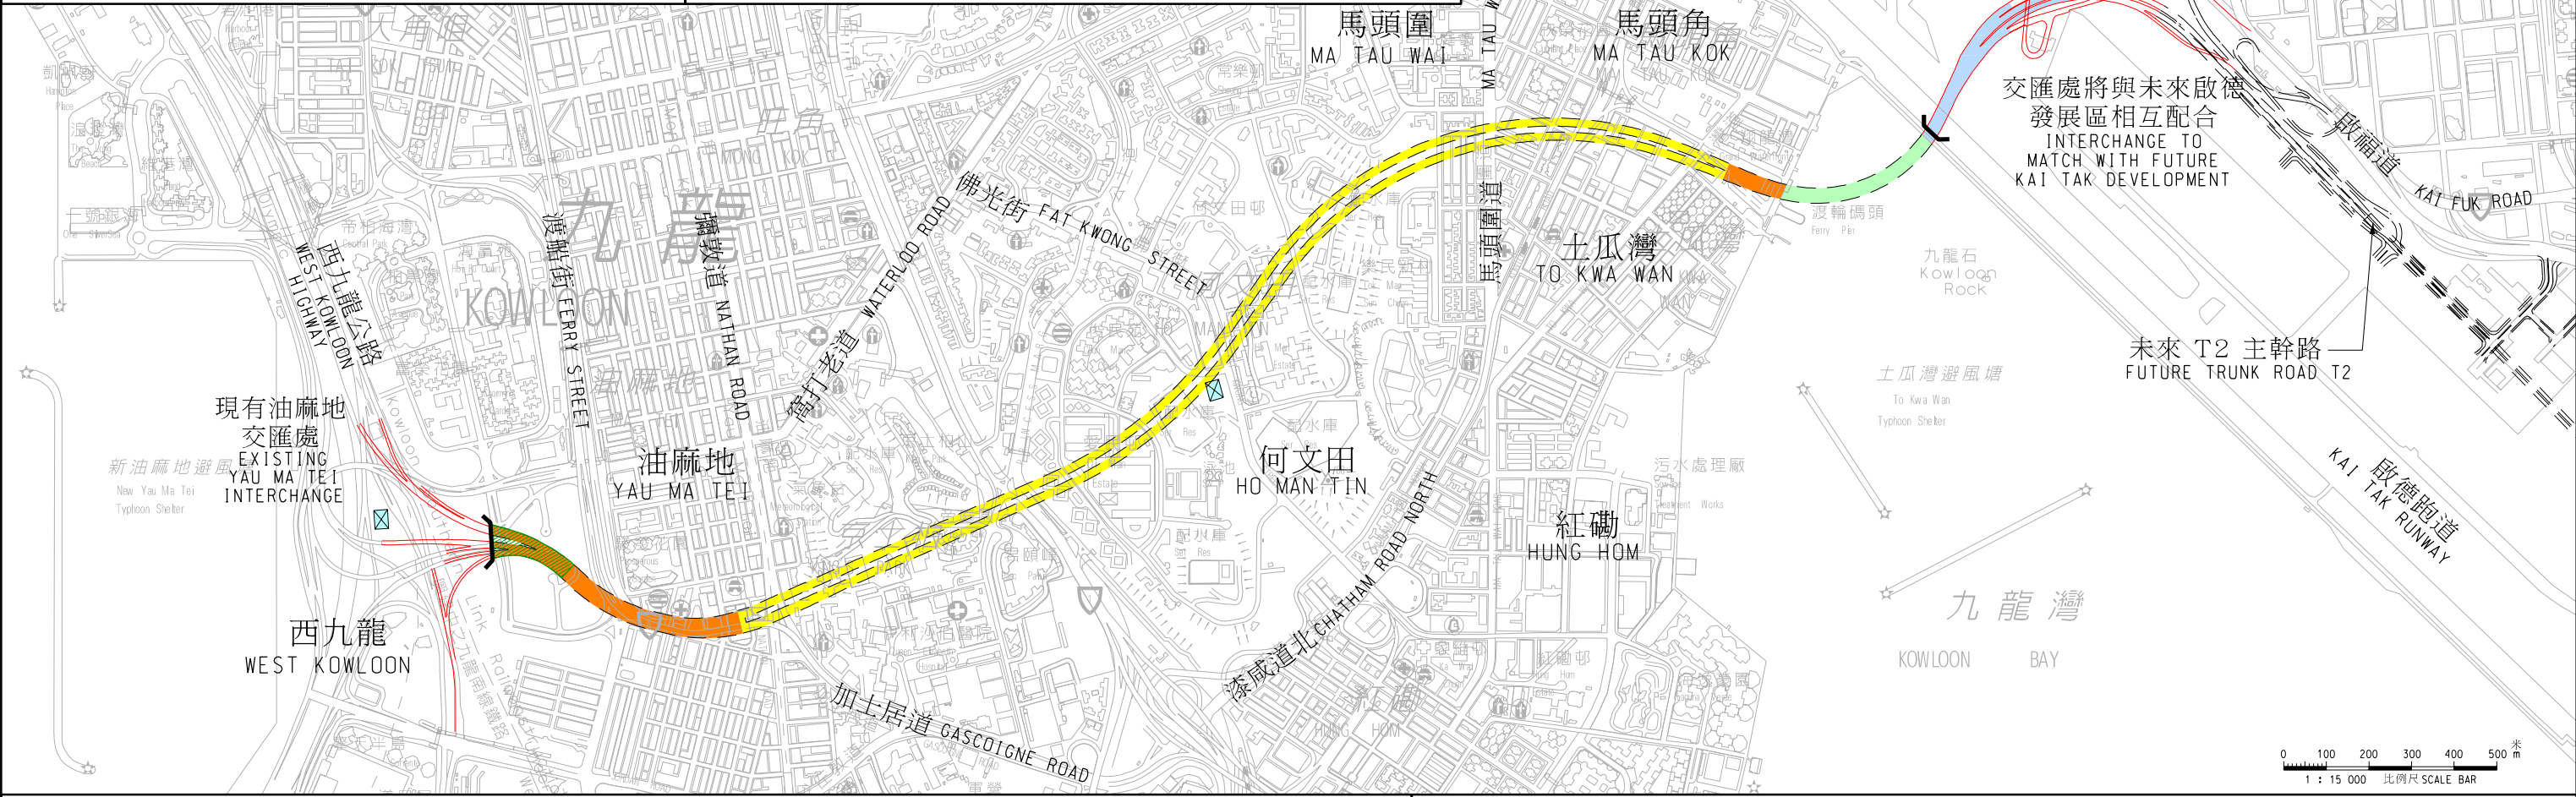

圖例 LEGEND :

- 擬建鑽挖式隧道 PROPOSED BORED TUNNEL
- 擬建明挖回填式隧道 PROPOSED CUT-AND-COVER TUNNEL
- 擬建海底隧道 PROPOSED UNDERWATER TUNNEL
- 擬建高架/地面道路 PROPOSED ELEVATED/AT-GRADE ROAD
- 擬建低於地面道路 PROPOSED DEPRESSED ROAD
- 擬建隧道出入口 PROPOSED TUNNEL PORTAL
- 擬建綠化平台 PROPOSED LANDSCAPED DECK
- 擬建通風大樓 PROPOSED VENTILATION BUILDING
- 擬建行政大樓 PROPOSED ADMINISTRATION BUILDING

圖則名稱 plan title	設計 designed K.T.YAU 20/02/09	SIGNED	繪圖 drawn L.B.LEUNG 20/02/09	SIGNED	圖則編號 plan no. HMW6461TH-SPO020	比例 scale 1:15000 或圖示 OR AS SHOWN
中九龍幹線 - 總平面圖 CENTRAL KOWLOON ROUTE - GENERAL LAYOUT PLAN	覆核 checked C.M.CHAN 20/02/09	SIGNED	批准 approved C.W.CHOW 20/02/09	SIGNED	© 版權所有 COPYRIGHT RESERVED	
主要工程管理處 MAJOR WORKS PROJECT MANAGEMENT OFFICE				HIGHWAYS DEPARTMENT HONG KONG 路政署		