


位置圖 KEY PLAN N.T.S. 不按比例

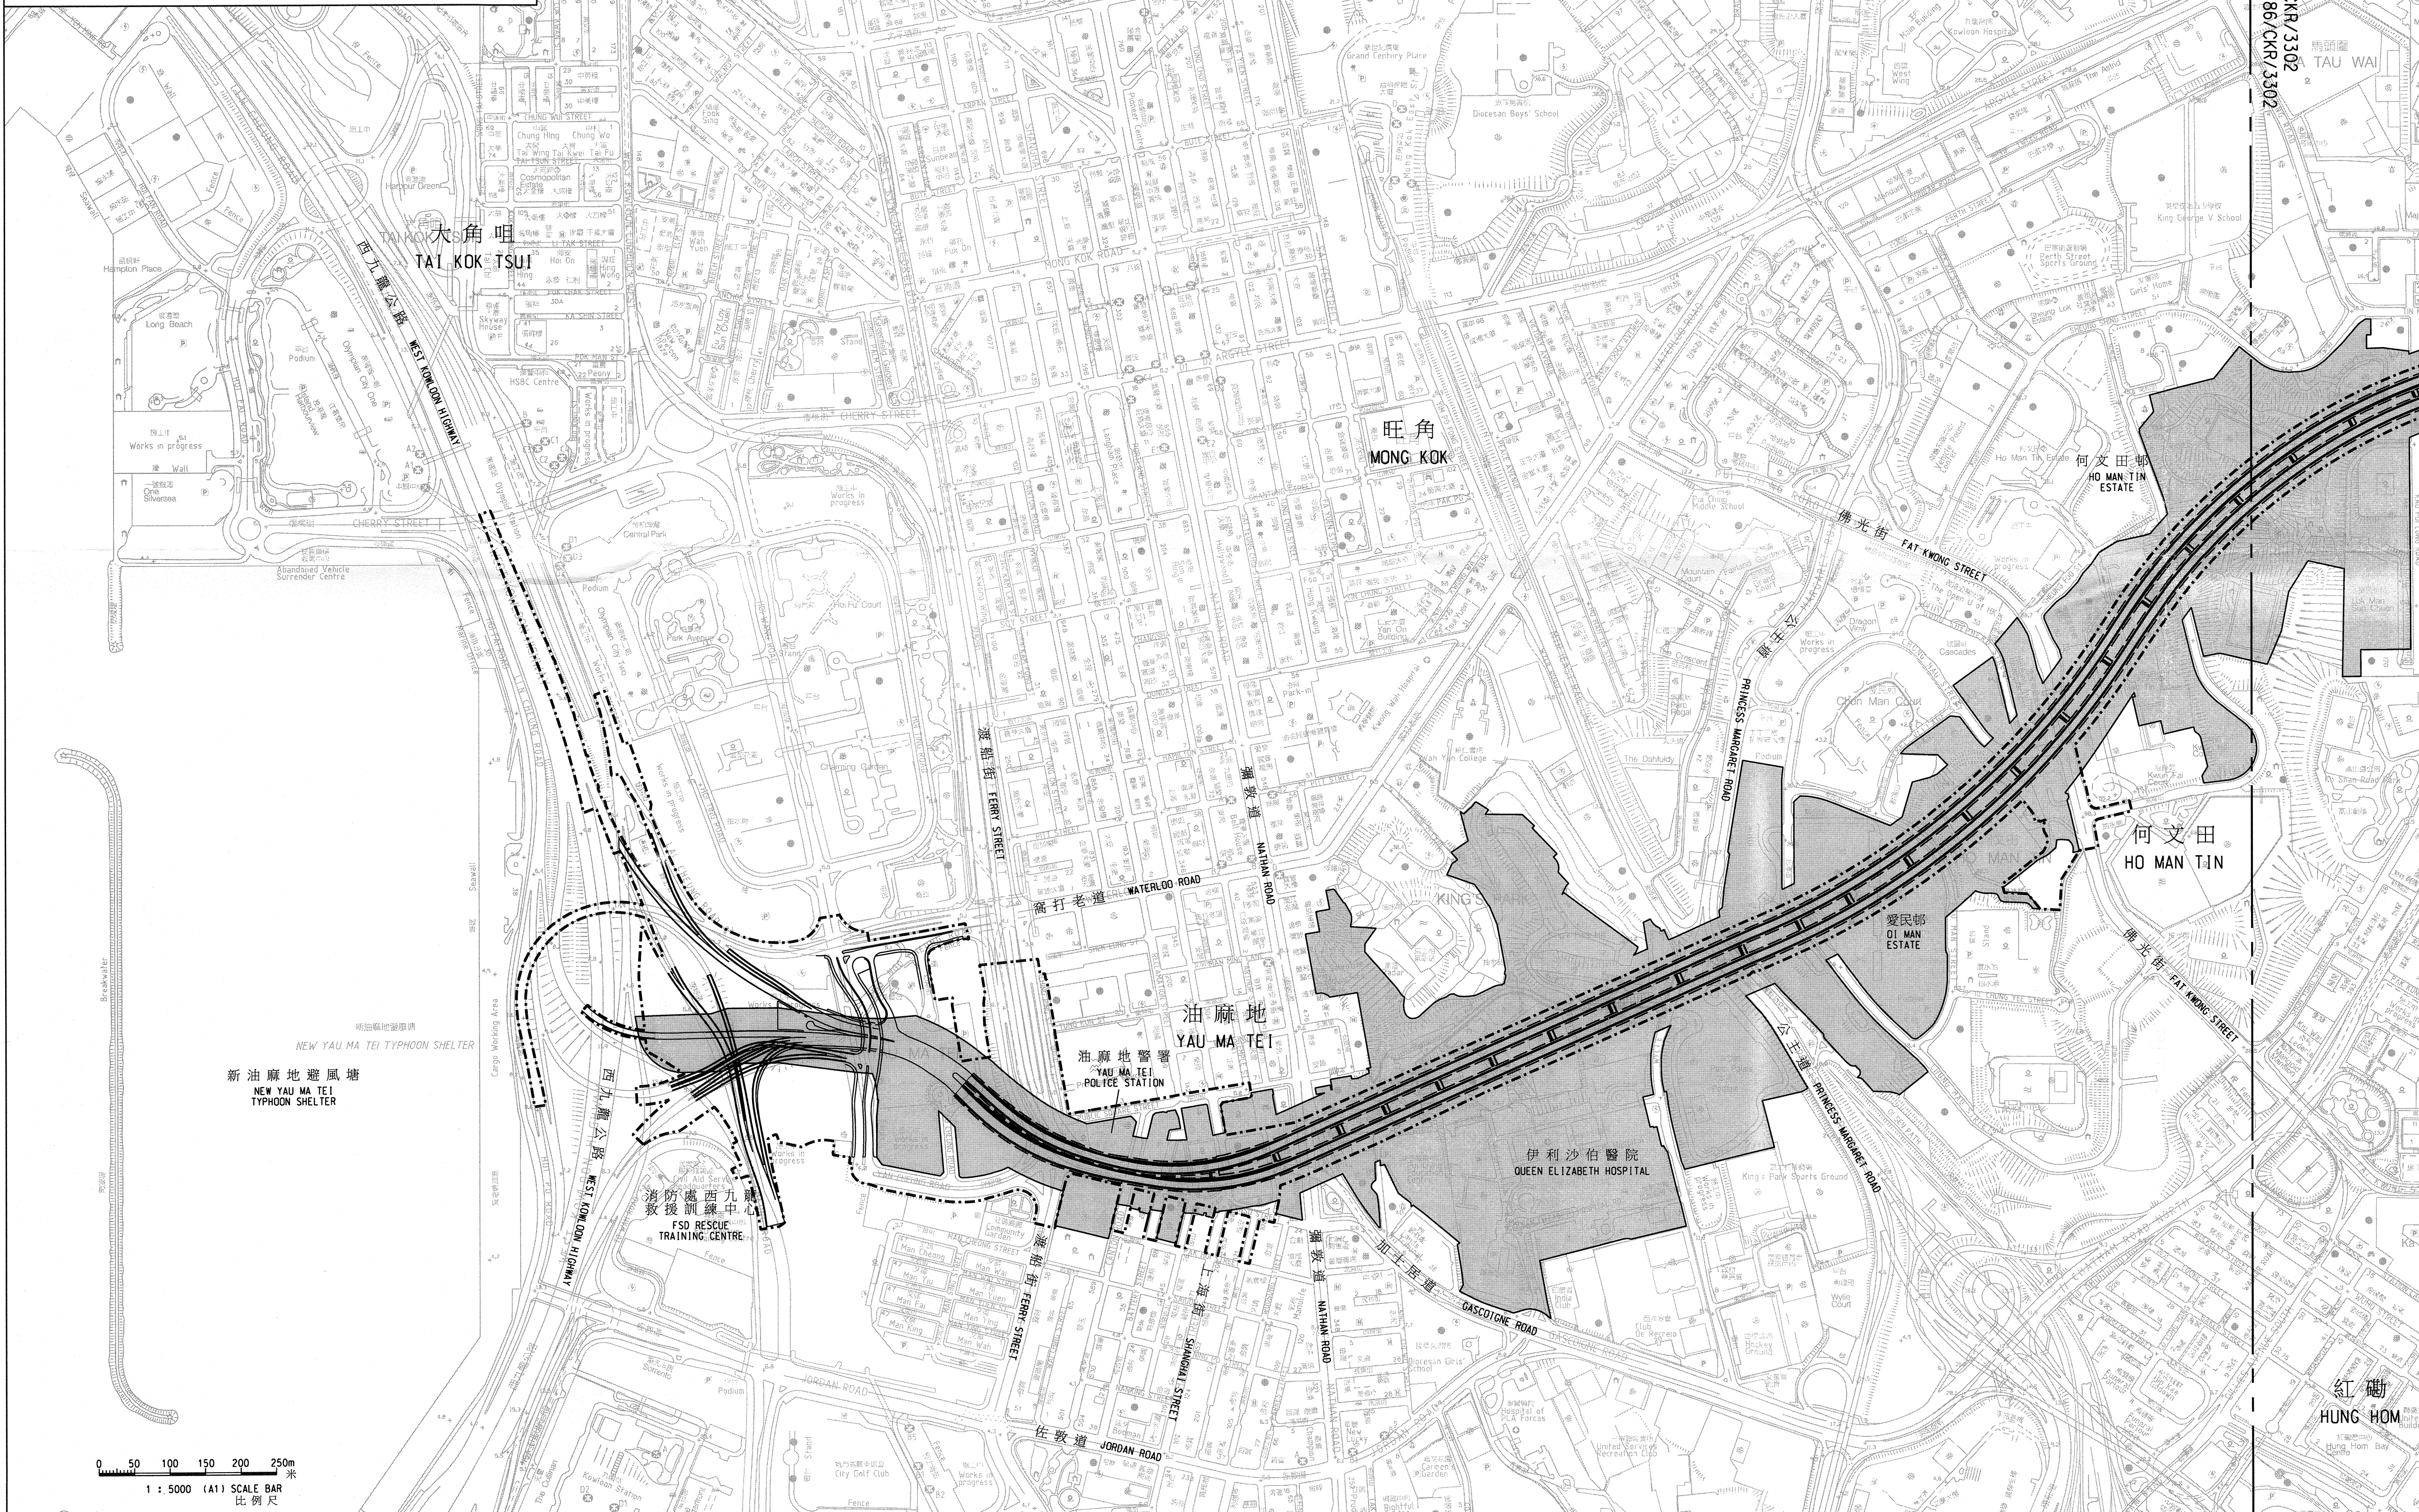

- 圖例 LEGEND :
- 施工區界限  
LIMIT OF WORKS AREA
  - 擬建之道路設施  
PROPOSED HIGHWAY FACILITIES
  - 就建築工程(包括在施工界限以外進行的建築工程)與工程或使用不相容, 可行使建築圖則或建築工程展開的的土地範圍  
AREA OF LAND ON WHICH CONTROL OF BUILDING PLANS OR COMMENCEMENT OF BUILDING WORKS INCLUDING BUILDING WORKS OUTSIDE THE WORKS AREA WHICH ARE INCOMPATIBLE WITH THE WORKS OR THE USE MAY BE REQUIRED

連接線 A-A 連接圖則編號 287786/CKR/3302  
MATCH LINE A-A CONTINUED ON PLAN NO. 287786/CKR/3302

(駱劍華 K W LOK)

路政署主要工程管理處總工程師(2)/主要工程  
CHIEF ENGINEER (2) / MAJOR WORKS  
MAJOR WORKS PROJECT MANAGEMENT OFFICE  
HIGHWAYS DEPARTMENT  
日期 DATE : 2010/10/2013

工程名稱 project title  
工務計劃項目第 6461TH 號  
中九龍幹線  
PWP ITEM NO. 6461TH  
CENTRAL KOWLOON ROUTE

圖則名稱 plan title  
<<道路(工程, 使用及補償) 條例>>  
(第370章)  
控制建築圖則及工程展開圖則  
ROADS (WORKS, USE AND COMPENSATION)  
ORDINANCE (CHAPTER 370)  
CONTROL OF BUILDING PLANS  
AND COMMENCEMENT OF WORK PLAN

圖則編號 plan no. 287786/CKR/3301

比例 scale 1: 5000 (A1)  
或如圖示 OR AS SHOWN

主要工程管理處  
MAJOR WORKS  
PROJECT MANAGEMENT OFFICE

路政署  
HIGHWAYS DEPARTMENT